

KEY NOTES	
1.	CORIAN COUNTERTOP 36" A.F.F.
2.	2"X4" WOOD STUDS @16" o.c. WITH INSULATION AND DRYWALL FINISH OF FIRE RESISTANCE OF 60 MINS

WINDOW SCHEDULE			
SYM	QTY	SIZE	TYPE
W1	6	48 X 48	AWNING WINDOW
W2	6	24 X 48	AWNING WINDOW

DOOR SCHEDULE			
SYM	QTY	SIZE	TYPE
D1	1	60"X80"	DOUBLE HUNG GLASS DOOR
D2	4	36"X80"	SOLID CORE TIMBER DOOR
D3	2	36"X80"	TIMBER POCKET DOOR
D4	1	30"X80"	SOLID CORE TIMBER DOOR

WALL LEGEND			
SYM	WIDTH	HEIGHT	DESCRIPTION
	8"	10'-0"	EXISTING 8" CONC. WALL
	5"	9'-3"	5" PARTITION WALL


1 FLOOR PLAN
1/4" = 1'-0"

JULIUS FERGUS
ST.PETERS MONTSERRAT
CELL: (664) 392-5148
juliusfergus@gmail.com


No.	Description	Date

SPCCU
OFFICE RENOVATION

FLOOR PLAN		A-01	
Project number	0001		
Date	16-01-2023		
Drawn by	JULIUS FERGUS		
Designed by	JULIUS FERGUS	Scale	As indicated

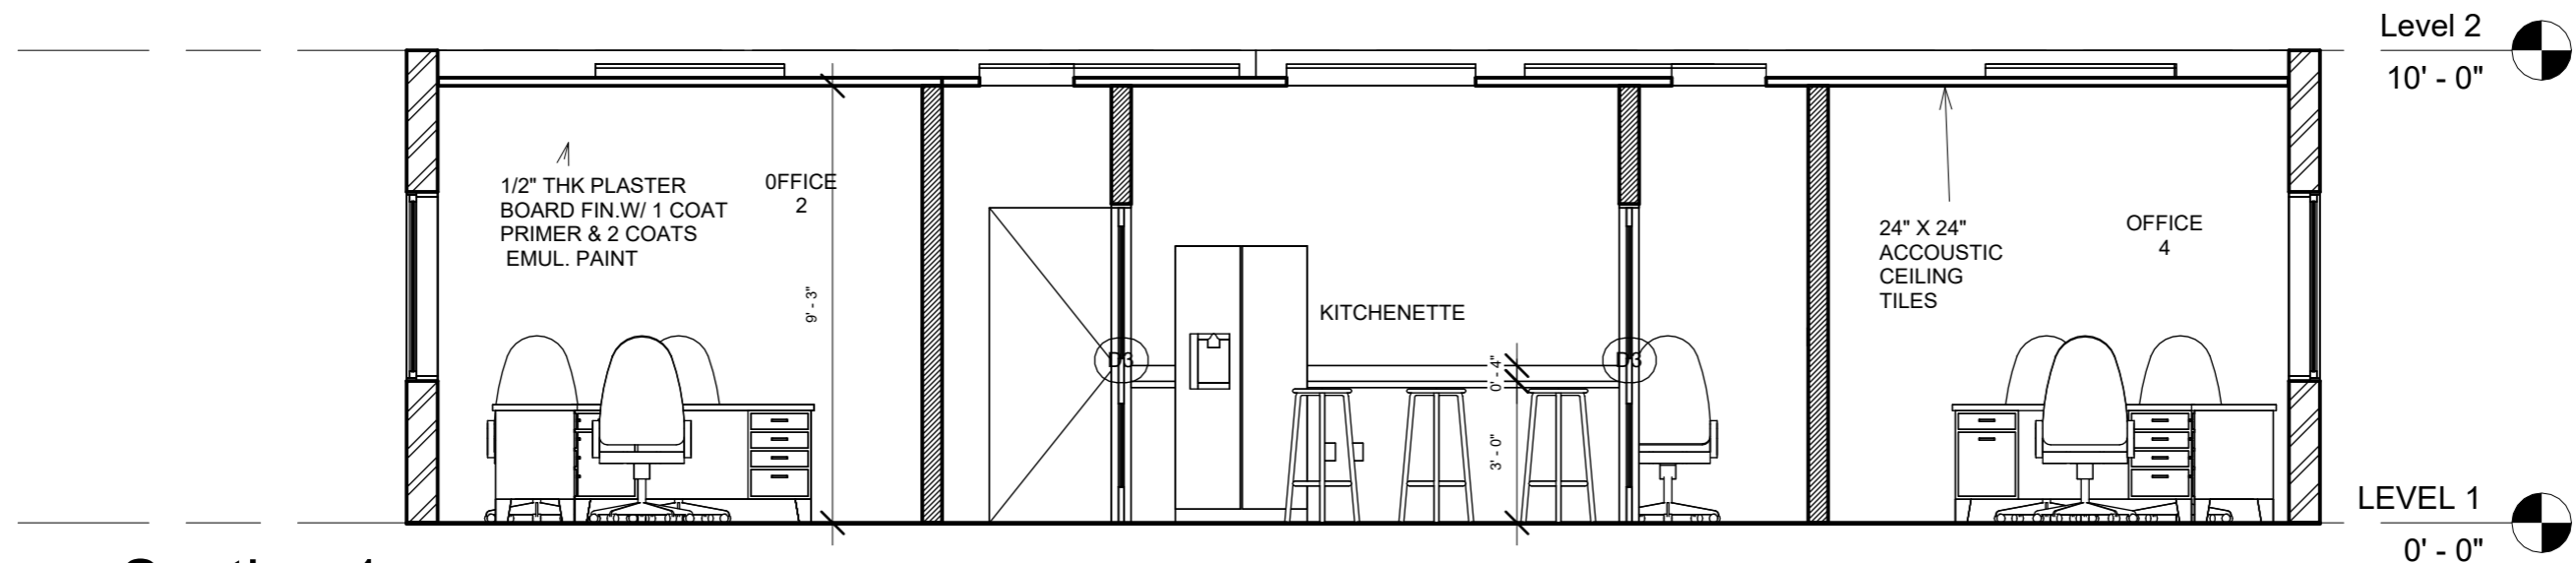

1 Section 1
1/4" = 1'-0"

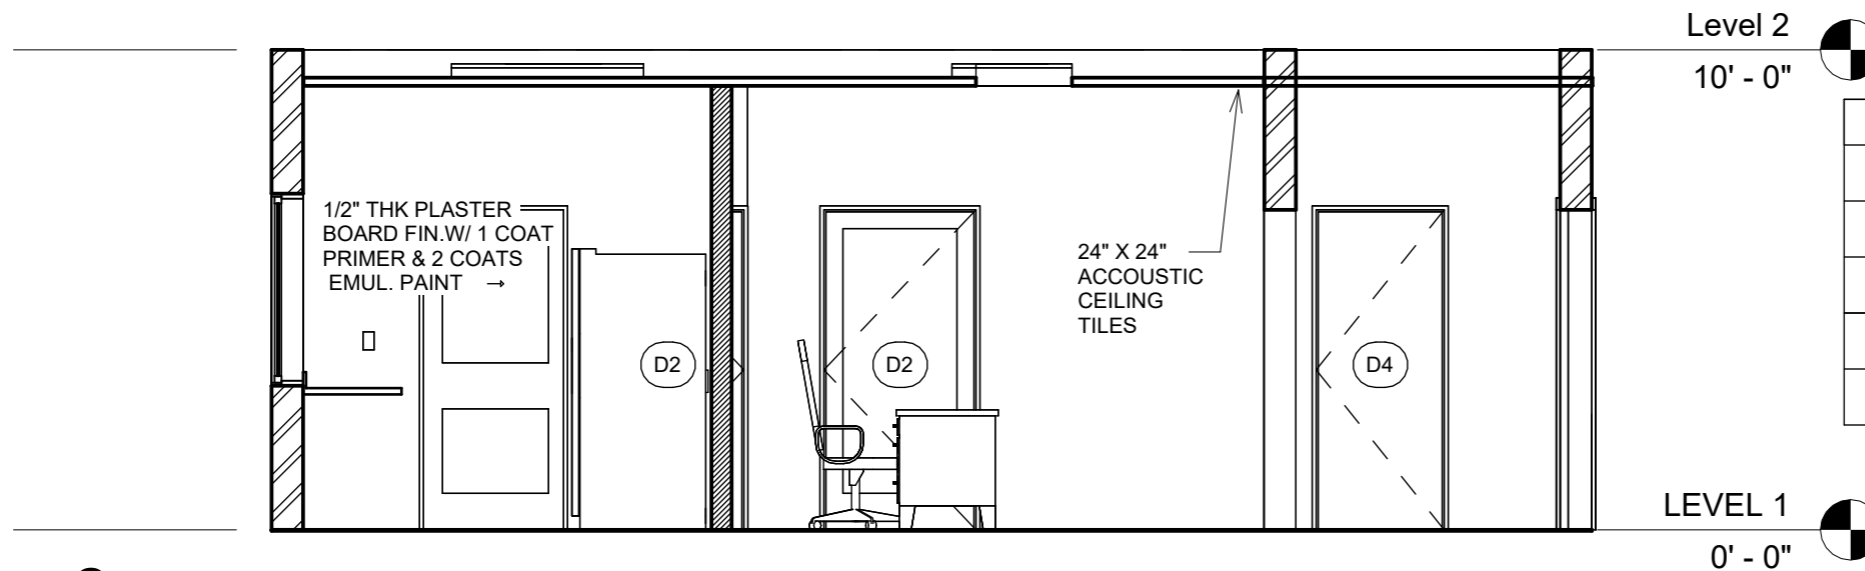

2 Section 2
1/4" = 1'-0"

DOOR SCHEDULE			
SYM	QTY	SIZE	TYPE
D1	1	60"X80"	DOUBLE HUNG GLASS DOOR
D2	4	36"X80"	SOLID CORE TIMBER DOOR
D3	2	36"X80"	TIMBER POCKET DOOR
D4	1	30"X80"	SOLID CORE TIMBER DOOR

WALL LEGEND			
SYM	WIDTH	HEIGHT	DESCRIPTION
	8"	10'-0"	EXISTING 8" CONC. WALL
	5"	9'-3"	5" PARTITION WALL

JULIUS FERGUS
ST.PETERS MONTSERRAT

CELL: (664) 392-5148

juliusfergus@gmail.com

No.	Description	Date

SPCCU


OFFICE RENOVATION

SECTION 1 & 2

Project number	0001
Date	16-01-2023
Drawn by	JULIUS FERGUS
Designed by	JULIUS FERGUS

A-02


Scale As indicated

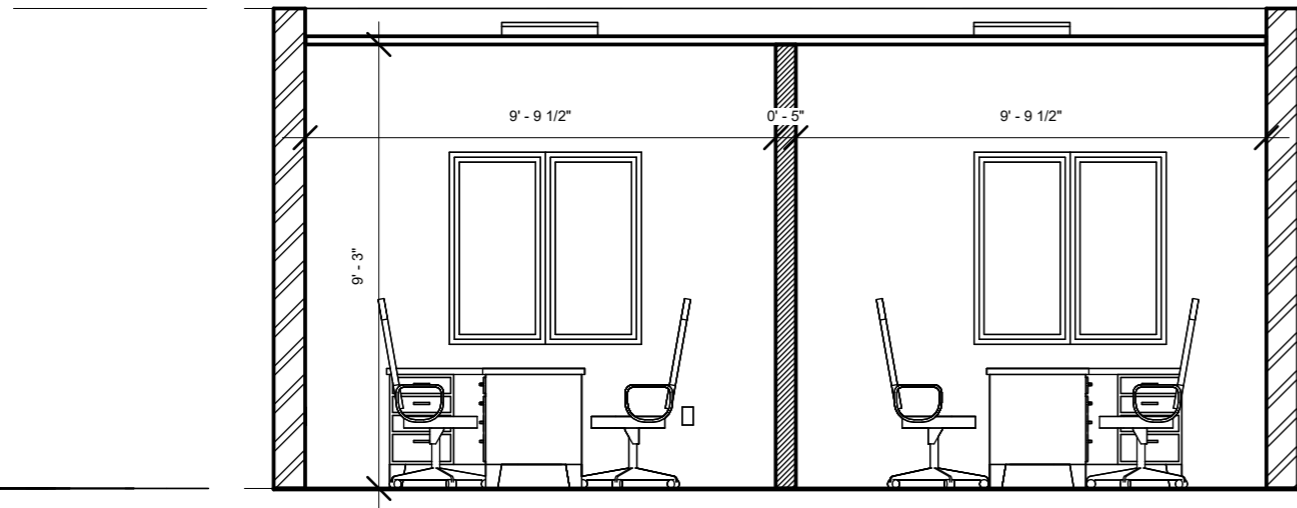

Level 2
10' - 0"

LEVEL 1
0' - 0"

1 Section 3
1/4" = 1'-0"

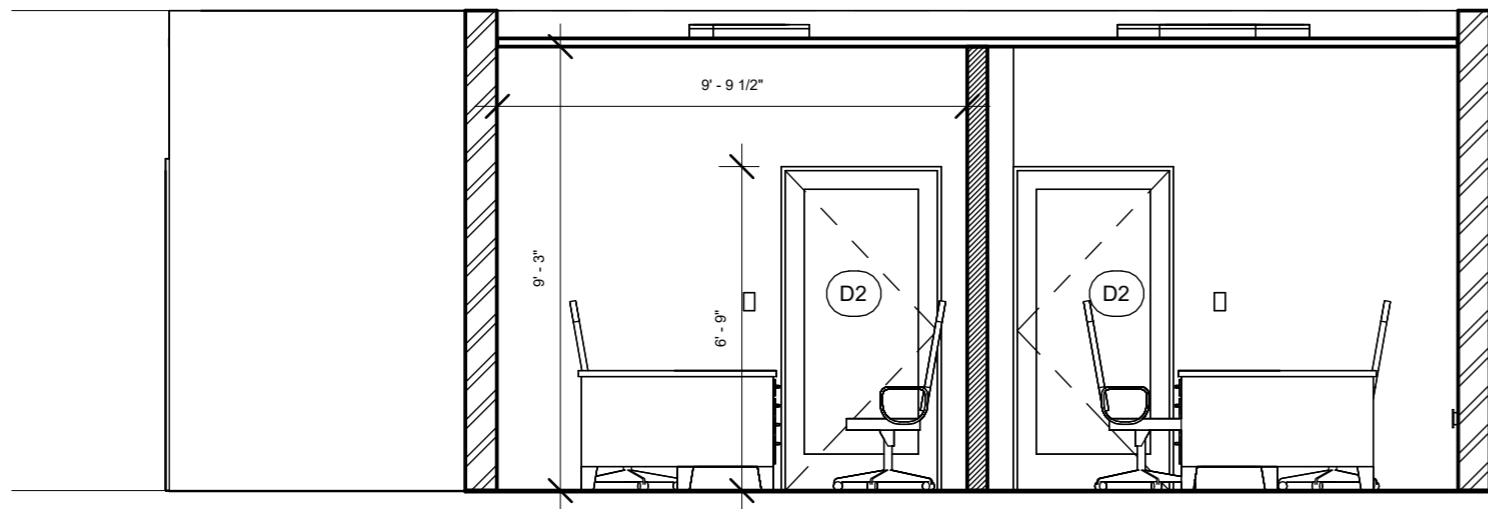

Level 2
10' - 0"

LEVEL 1
0' - 0"

2 Section 4
1/4" = 1'-0"

DOOR SCHEDULE			
SYM	QTY	SIZE	TYPE
D1	1	60"X80"	DOUBLE HUNG GLASS DOOR
D2	4	36"X80"	SOLID CORE TIMBER DOOR
D3	2	36"X80"	TIMBER POCKET DOOR
D4	1	30"X80"	SOLID CORE TIMBER DOOR

WALL LEGEND			
SYM	WIDTH	HEIGHT	DESCRIPTION
	8"	10'-0"	EXISTING 8" CONC. WALL
	5"	9'-3"	5" PARTITION WALL

JULIUS FERGUS
ST.PETERS MONTSERRAT

CELL: (664) 392-5148

juliusfergus@gmail.com

No.	Description	Date

SPCCU


OFFICE RENOVATION

SECTION 3 & 4

Project number	0001
Date	16-01-2023
Drawn by	JULIUS FERGUS
Designed by	JULIUS FERGUS

A-03

Scale As indicated

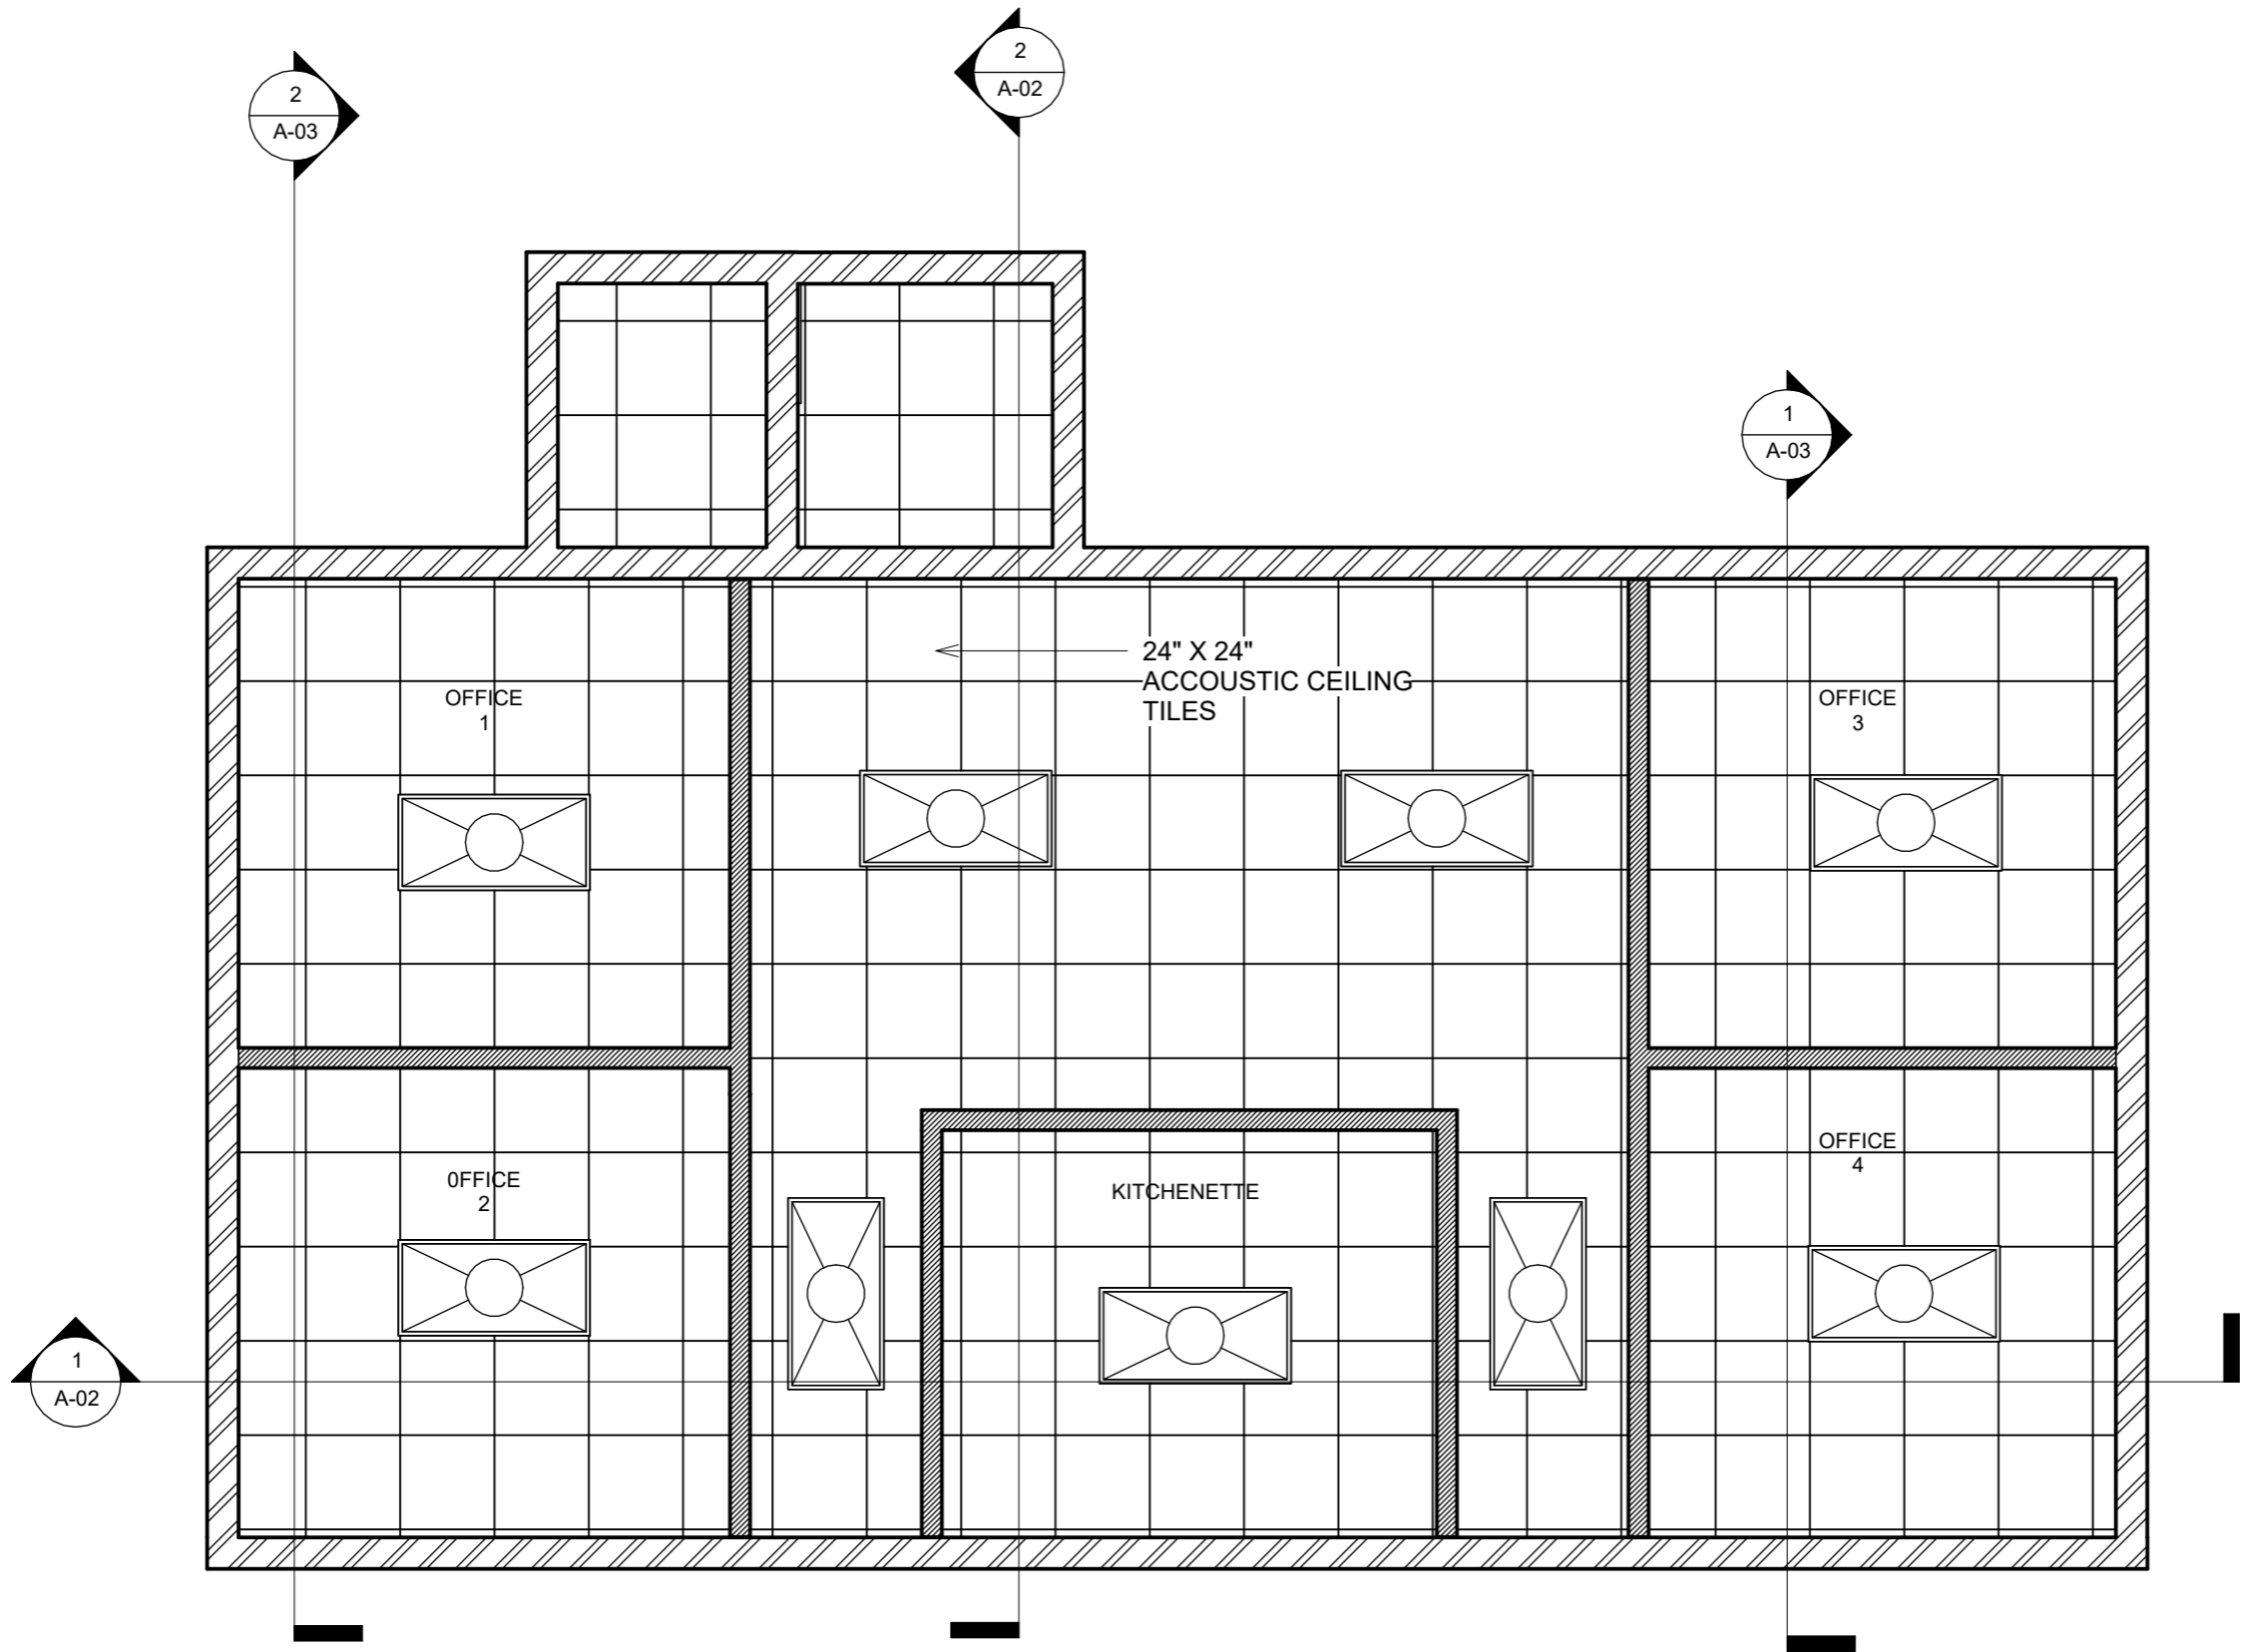

REFLECTED CIELING

1 PLAN 1/4" = 1'-0"

JULIUS FERGUS
ST.PETERS MONTSERRAT

CELL: (664) 392-5148

juliusfergus@gmail.com

No.	Description	Date

SPCCU


OFFICE RENOVATION

RFLECTED CEILING PLAN


Project number	0001
Date	16-01-2023
Drawn by	Author
Designed by	Checker

A-04

Scale 1/4" = 1'-0"

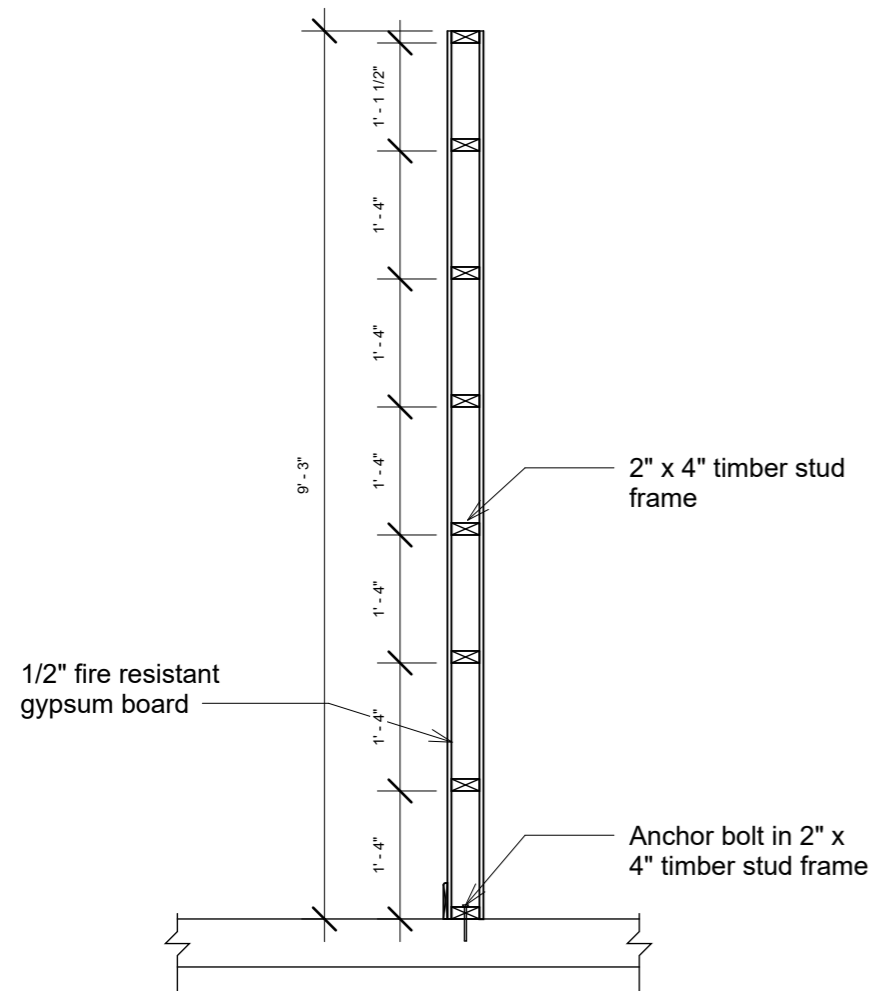

D-1 WALL DETAIL
SCALE 1/2" = 1'-0"

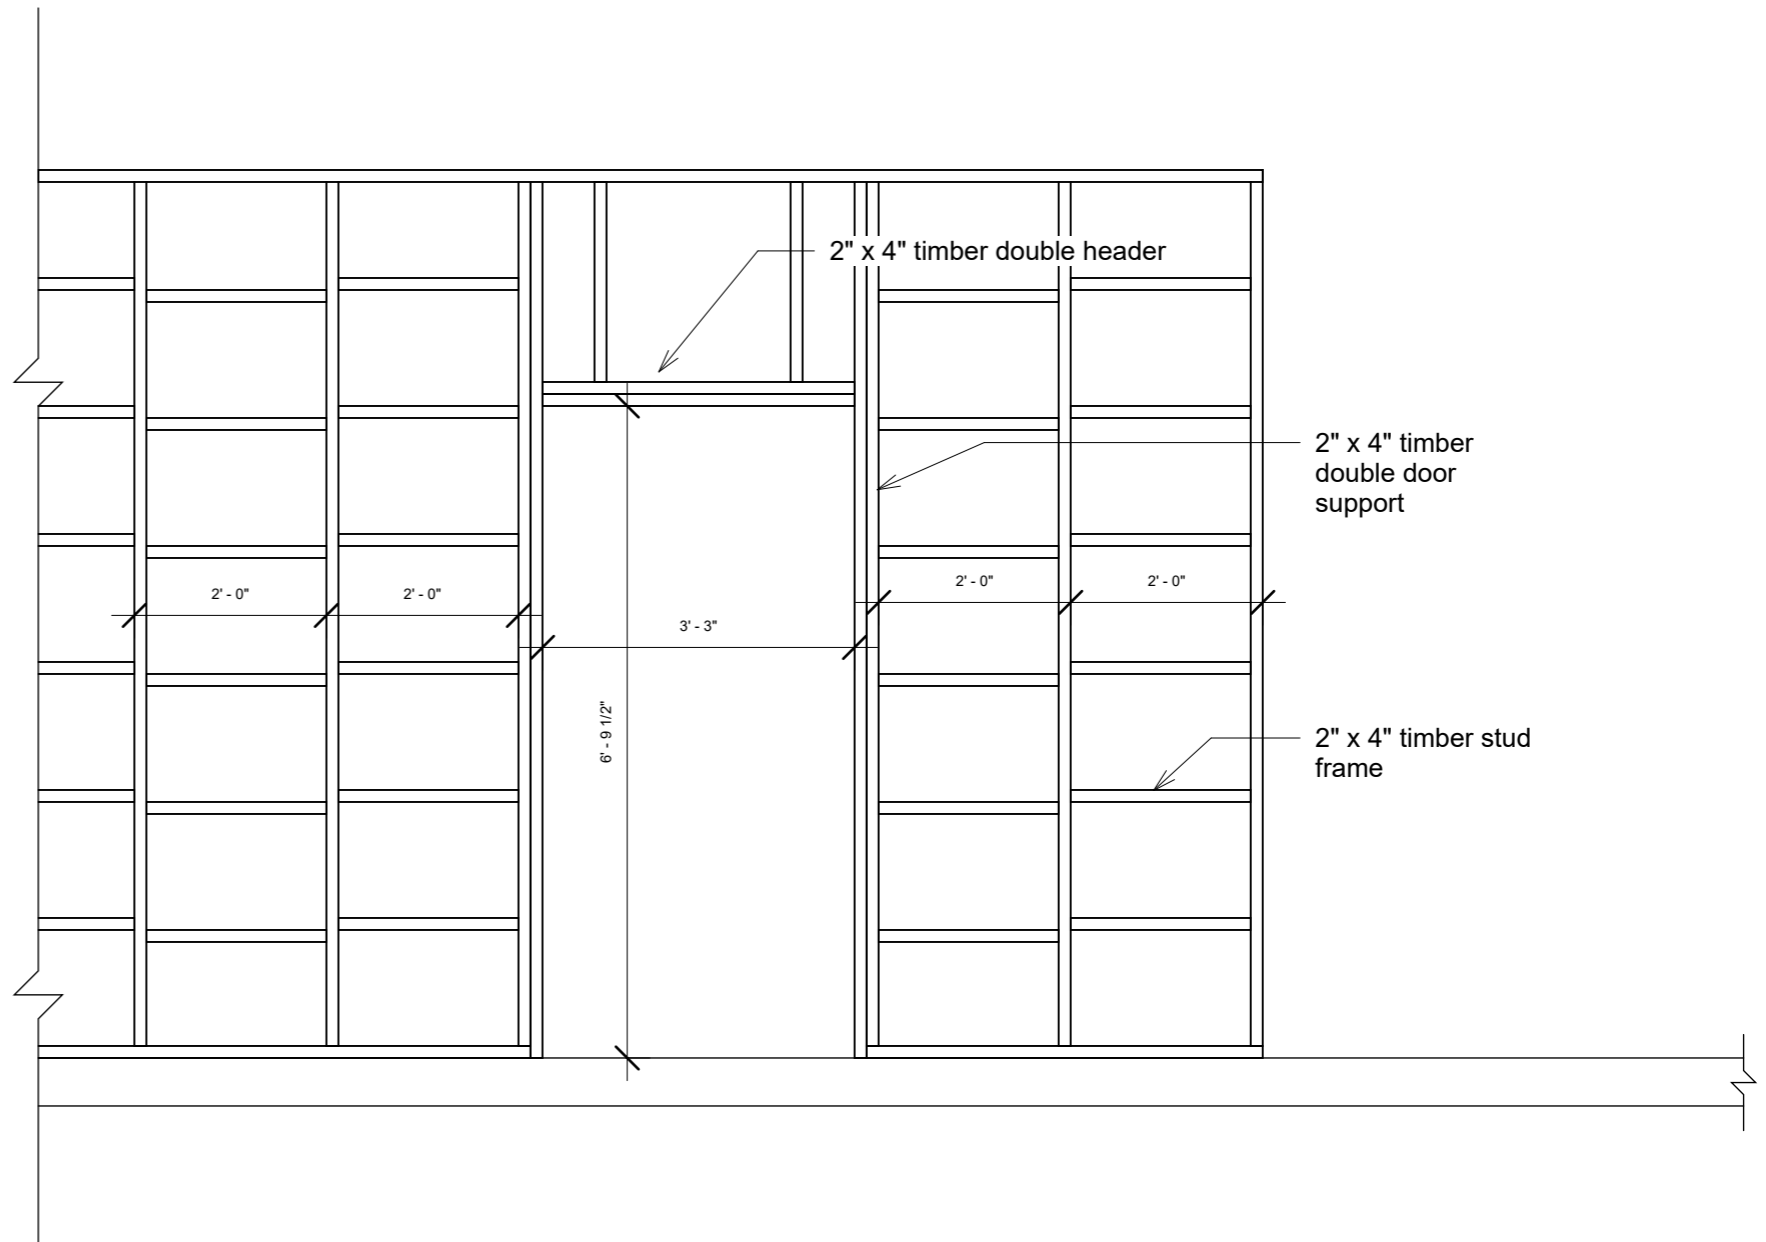

D-2 TYPICAL DOOR FRAME
SCALE 1/2" = 1'-0"

1 Wall Details
1/2" = 1'-0"

JULIUS FERGUS
ST.PETERS MONTSERRAT

CELL: (664) 392-5148

juliusfergus@gmail.com

No.	Description	Date

SPCCU



OFFICE RENOVATION

WALL DETAILS

Project number	0001
Date	16-01-2023
Drawn by	Author
Designed by	Checker

A-05

Scale 1/2" = 1'-0"

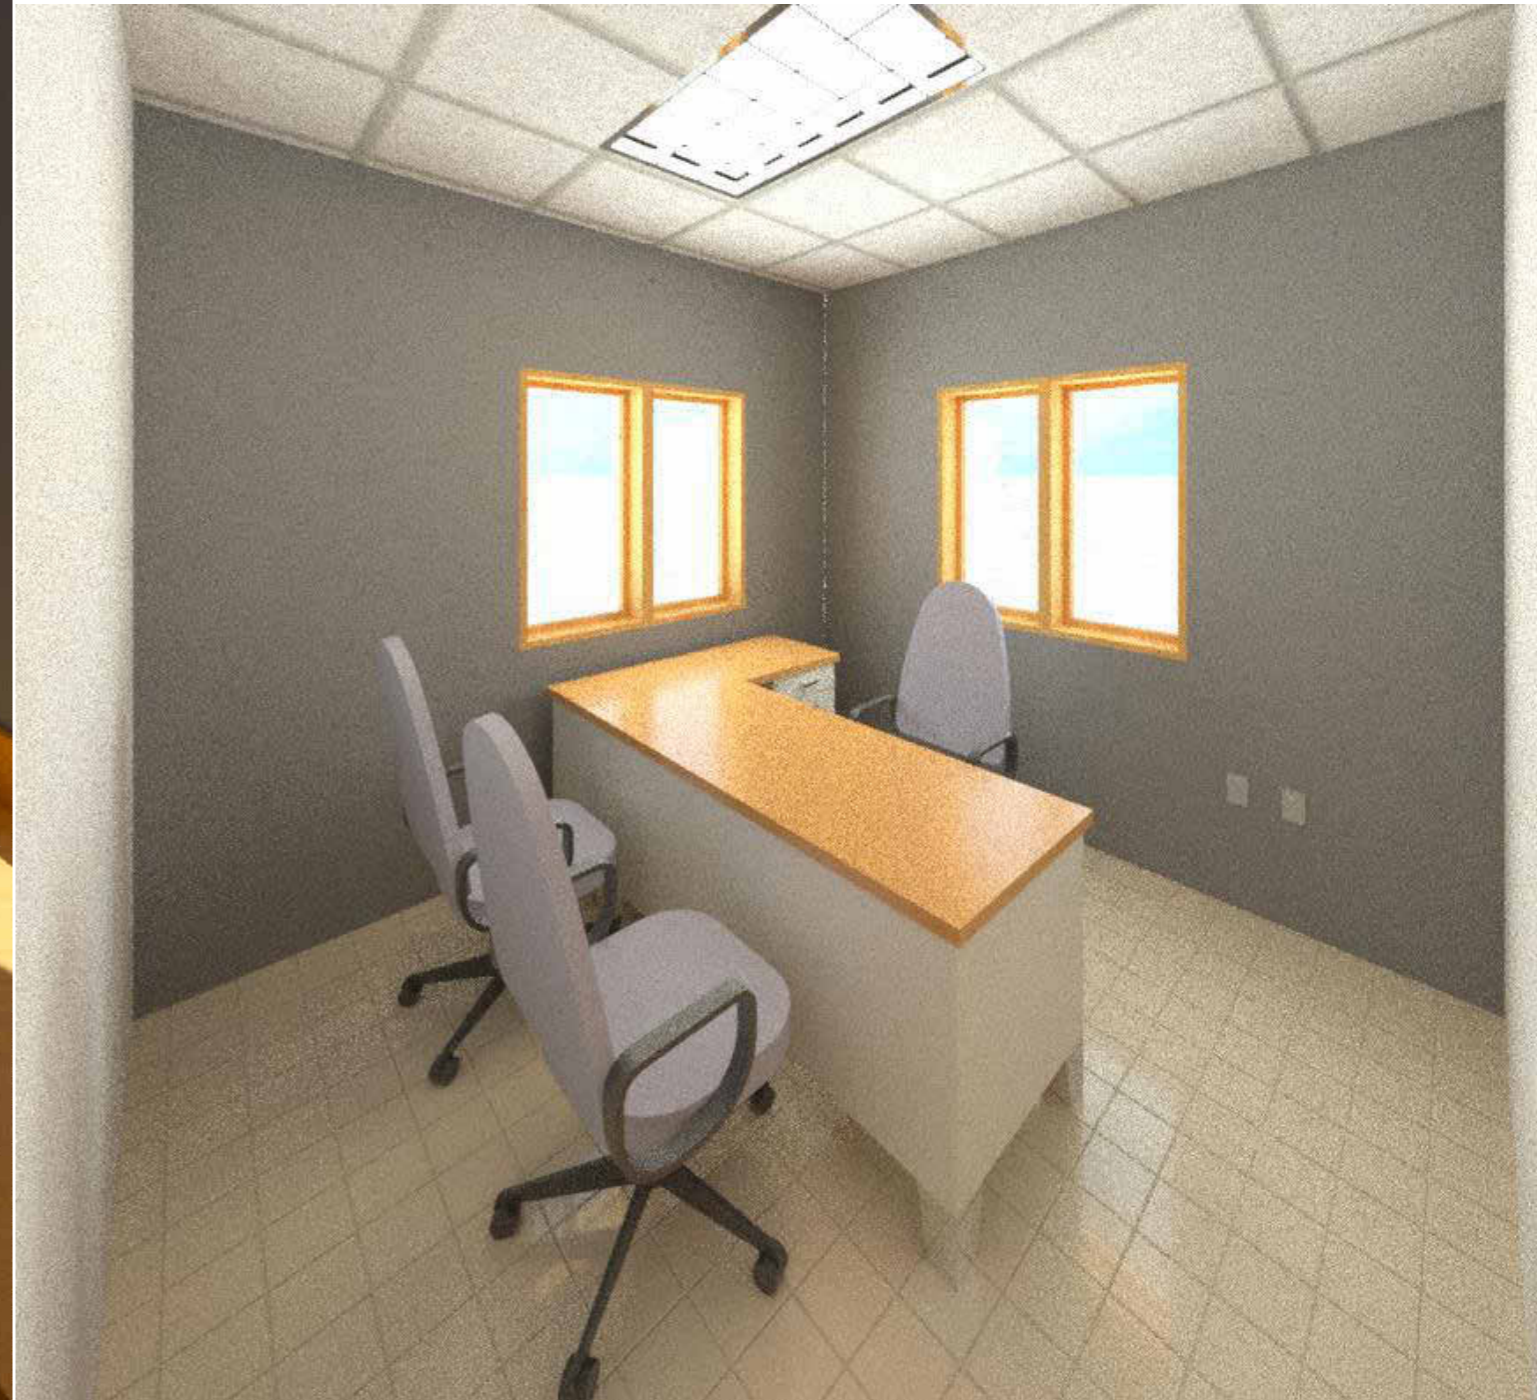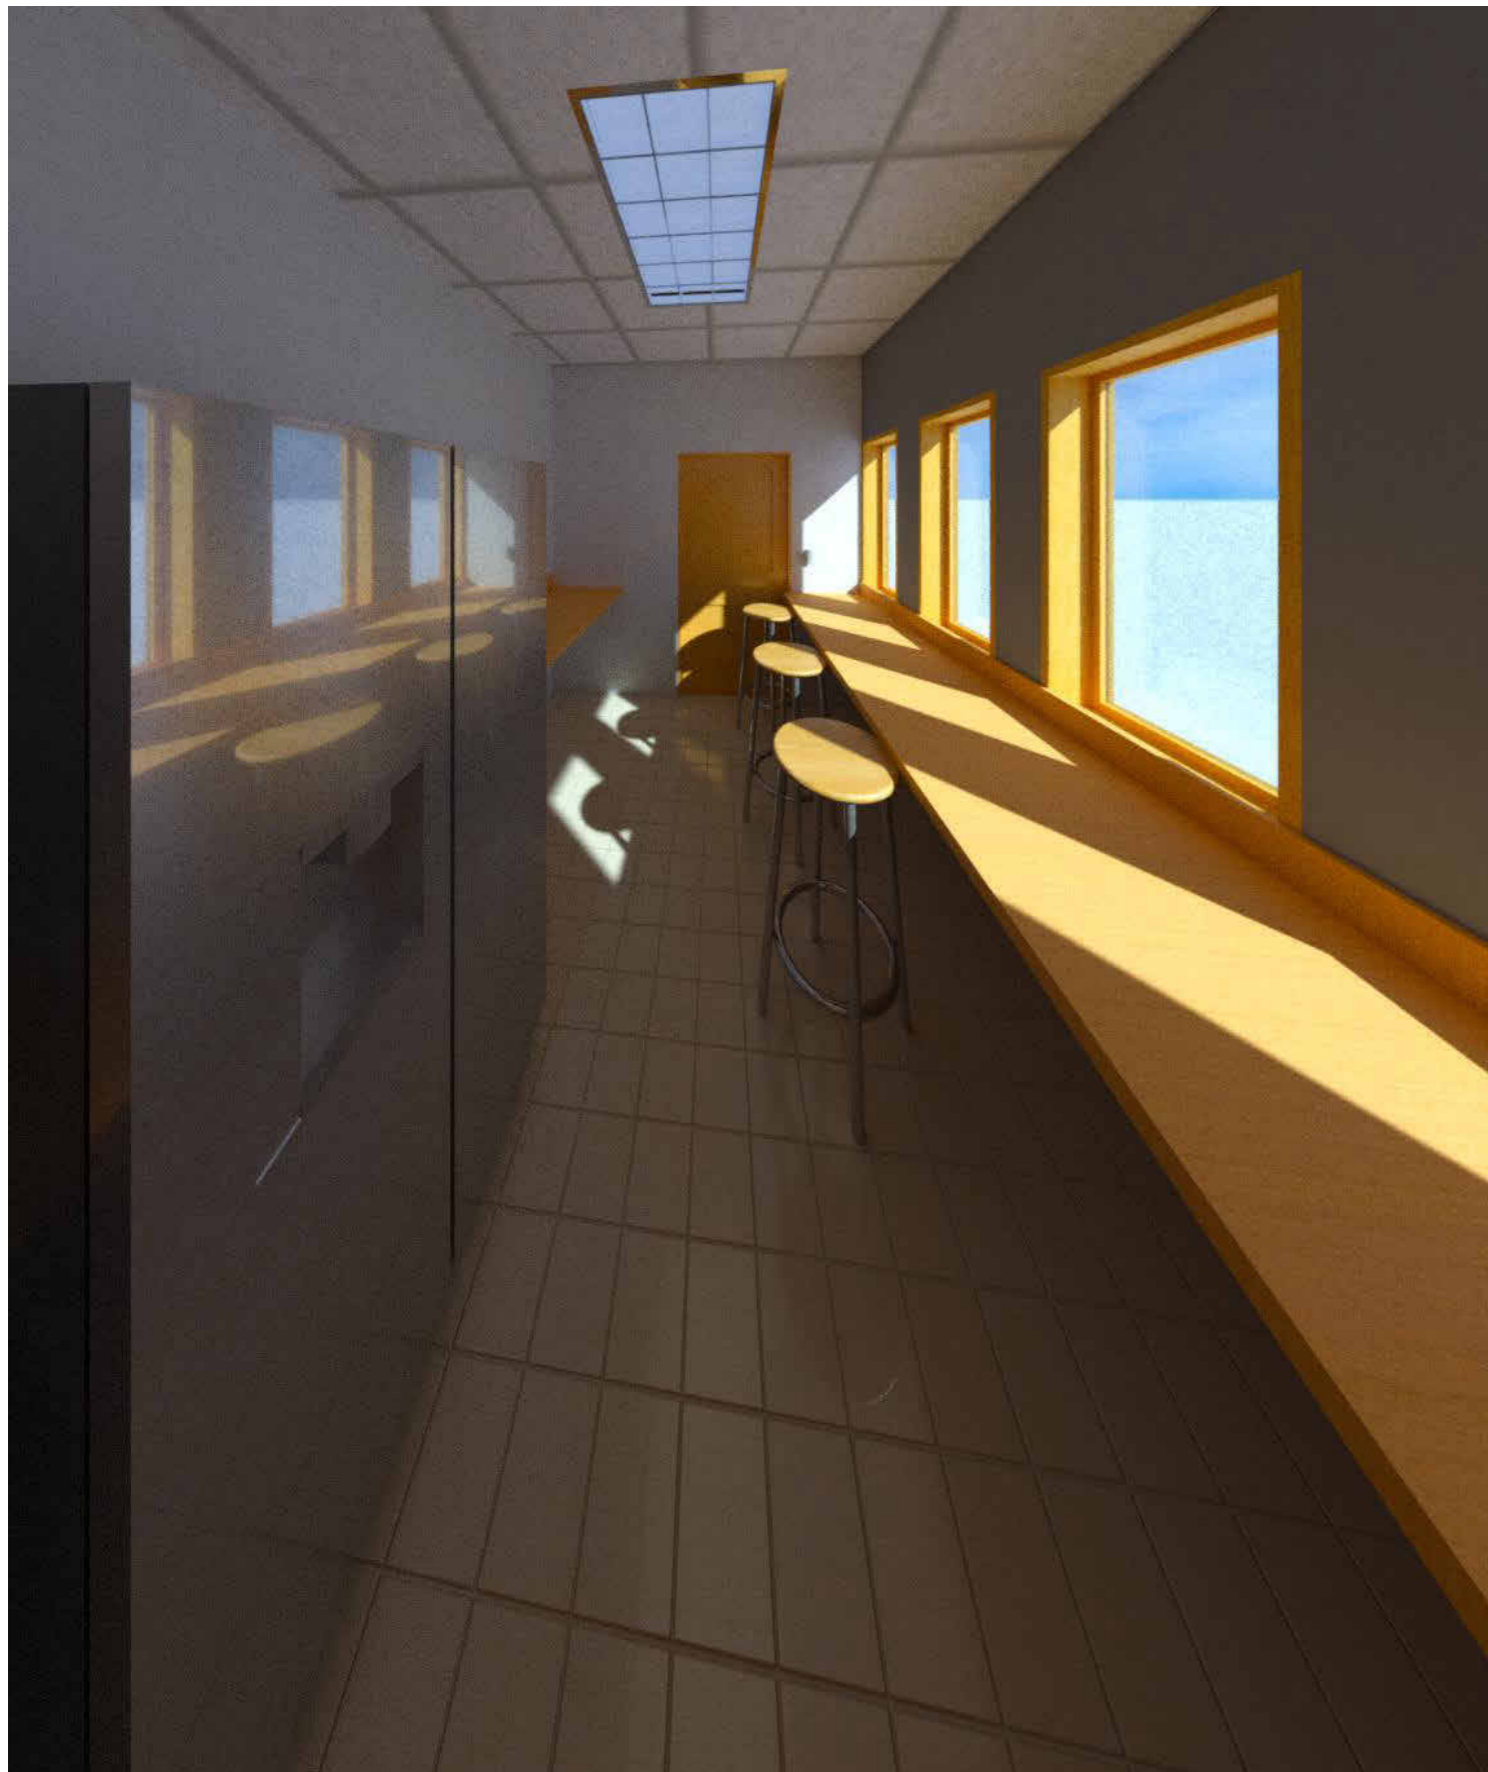

JULIUS FERGUS
ST.PETERS MONTSERRAT

CELL: (664) 392-5148

juliusfergus@gmail.com

No.	Description	Date

SPCCU


OFFICE RENOVATION

Kitchenette and Office 4 3D view

Project number	0001
Date	16-01-2023
Drawn by	Author
Designed by	Checker

A-06

Scale 12" = 1'-0"

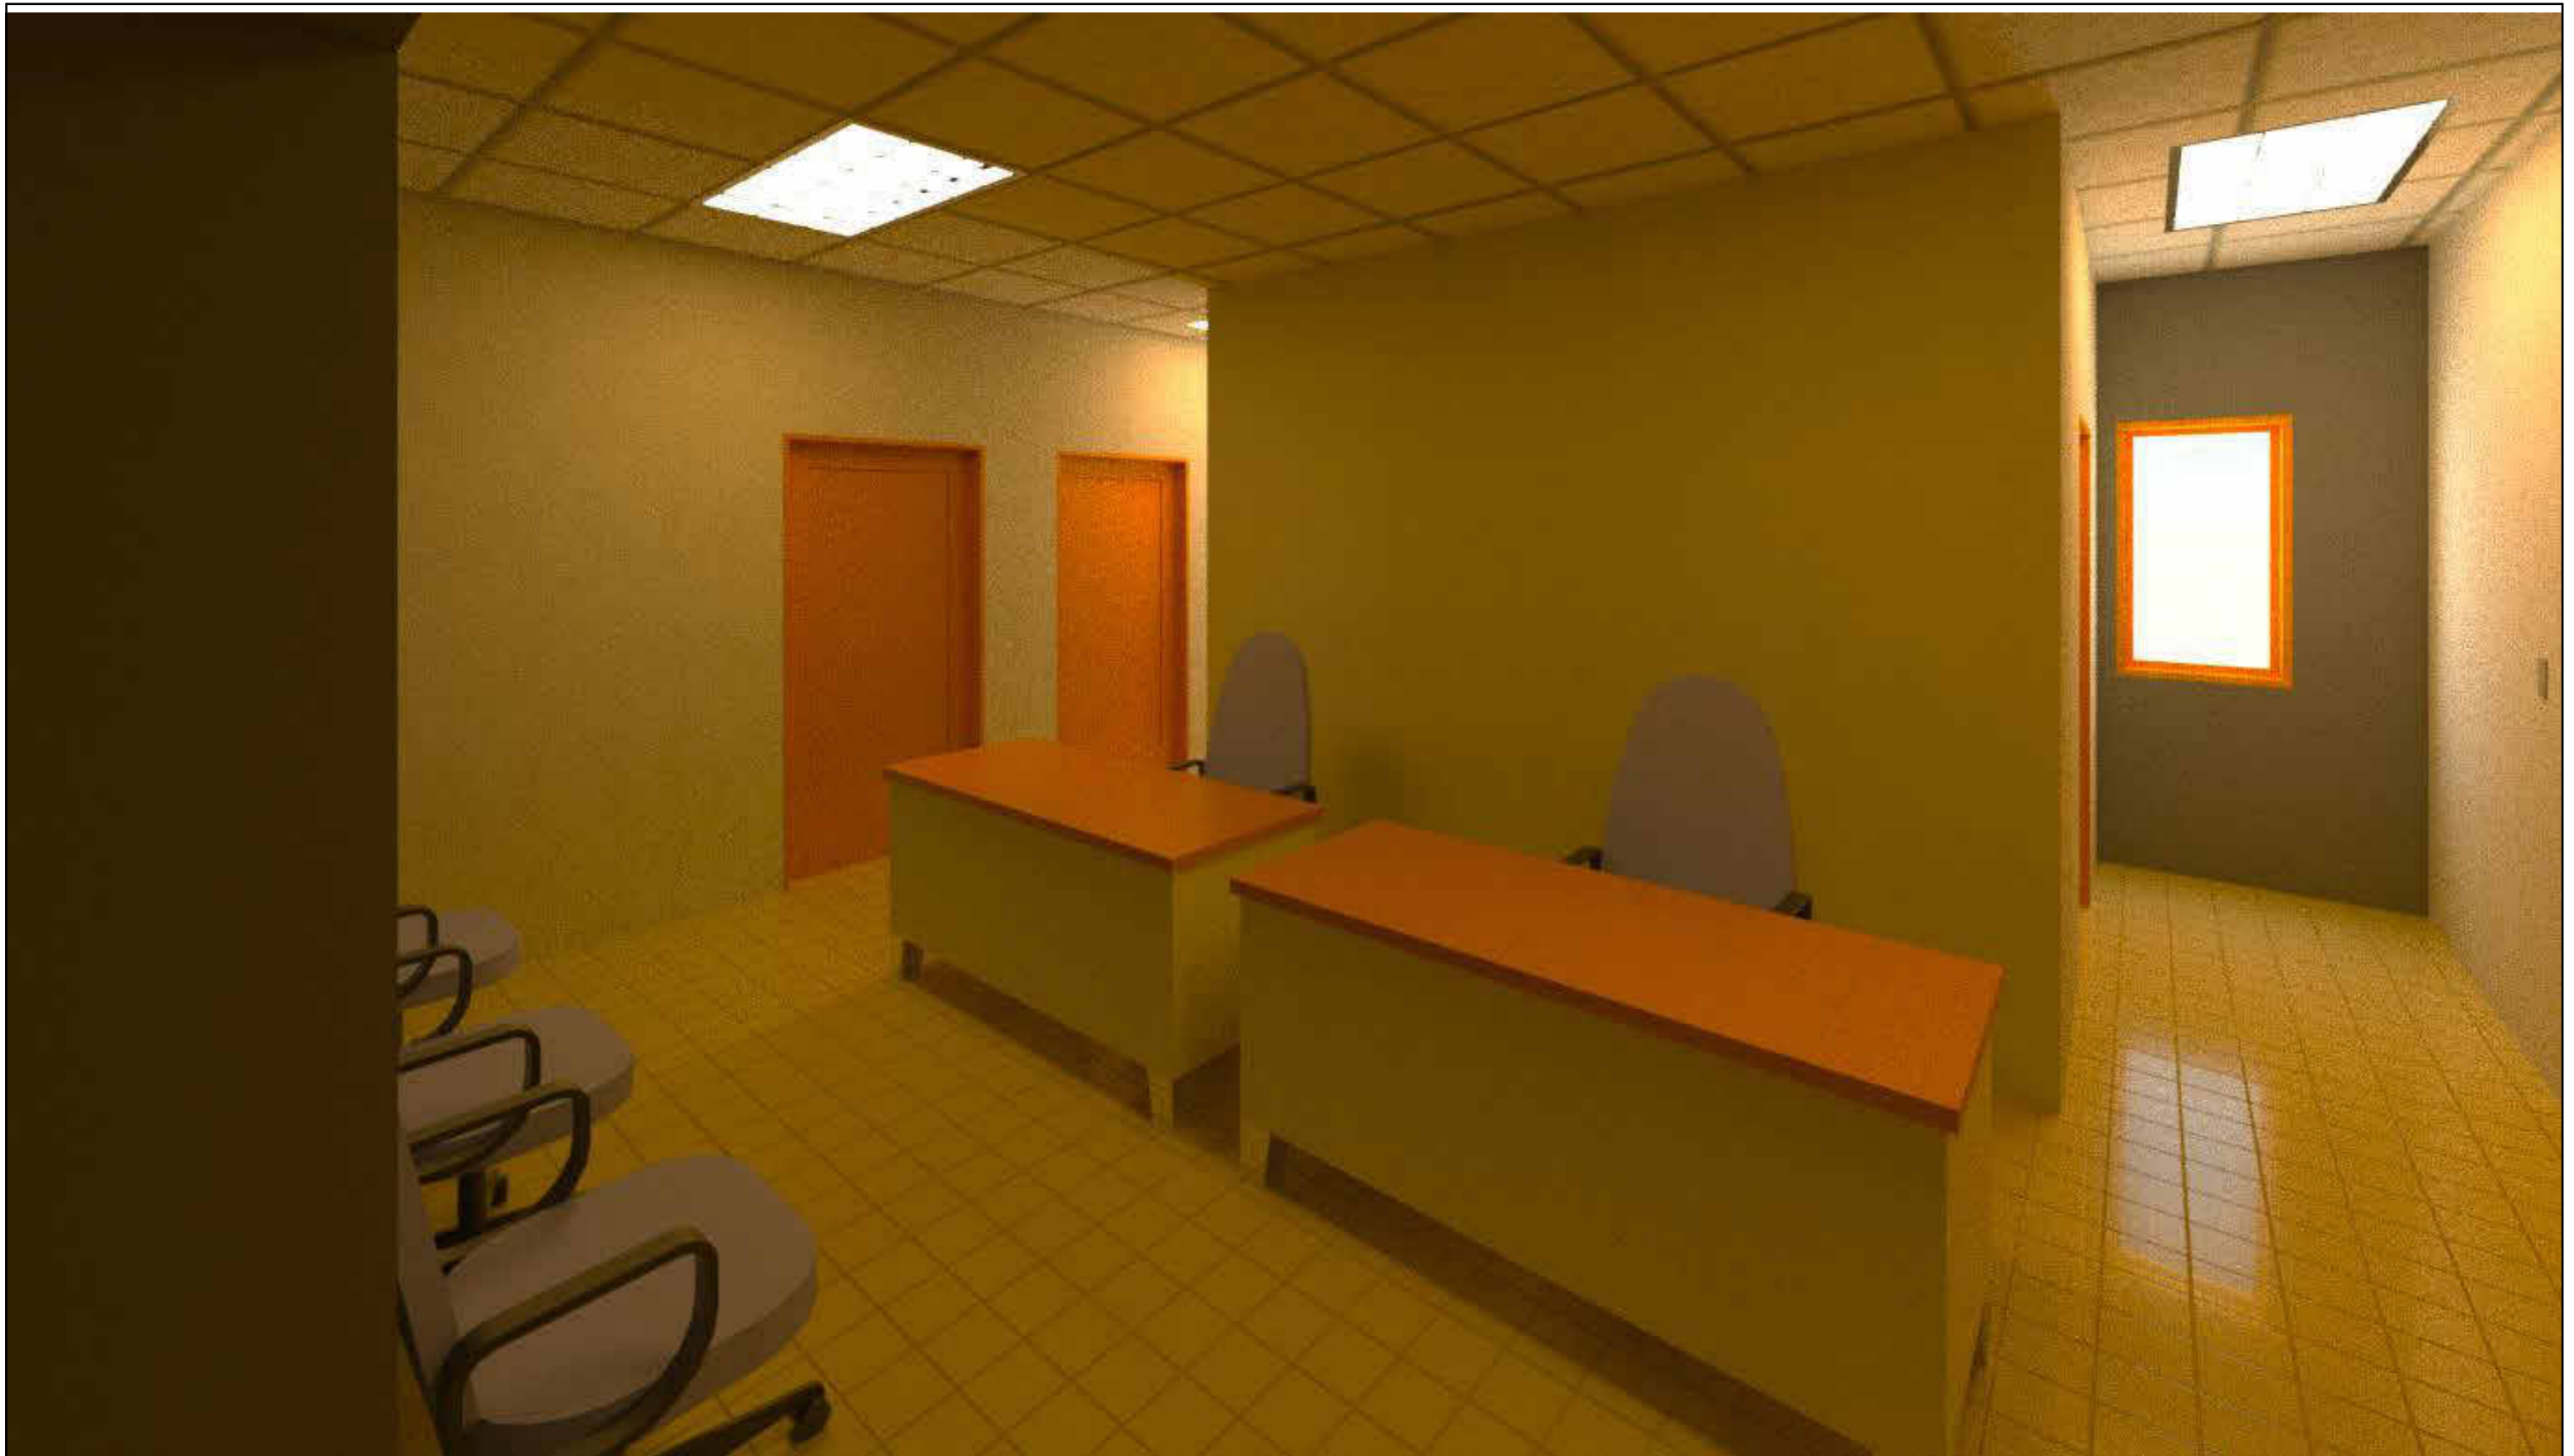

JULIUS FERGUS
ST.PETERS MONTSERRAT

CELL: (664) 392-5148

 

 

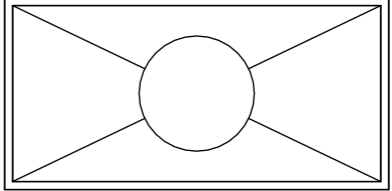
juliusfergus@gmail.com


No.	Description	Date

SPCCU

OFFICE RENOVATION

Lobby 3D view		A-07
Project number	0001	
Date	16-01-2023	12" = 1'-0"
Drawn by	Author	
Designed by	Checker	

ELECTRICAL LEGEND		
No.	SYM	DESCRIPTION
10		SINGLE POLE SWITCH
7		220V OUTLET 18" A.F.F.
4		120V OUTLET 18" A.F.F.
3		DATA AND TELEPHONE
9		24"X48" RECESSED CEILING MOUNTED LIGHT FIXTURE

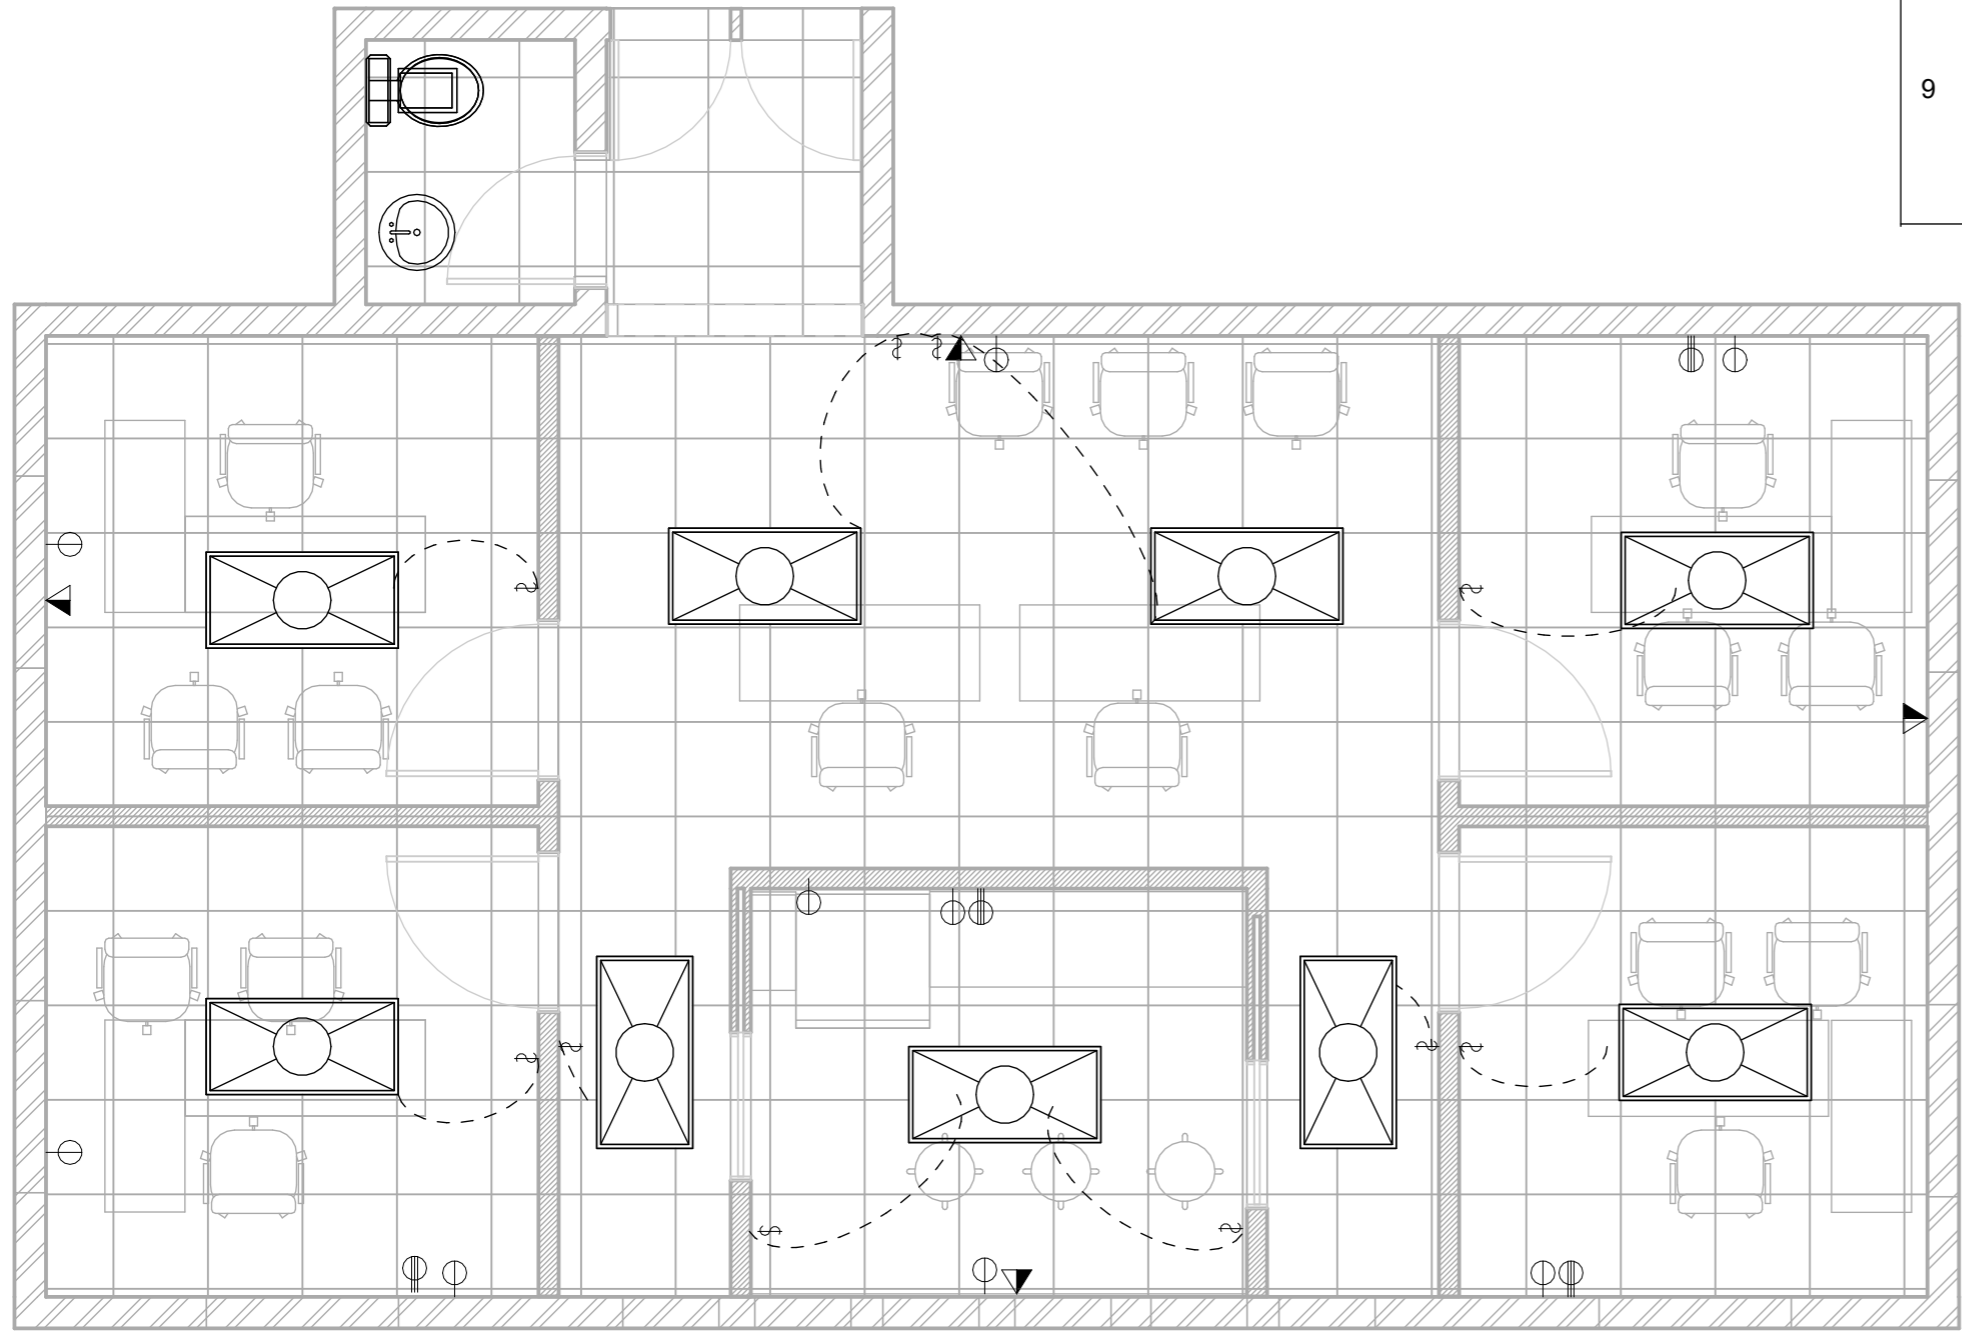

1 ELECTRICAL PLAN
1/4" = 1'-0"

JULIUS FERGUS CELL: (664) 392-5148
ST.PETERS MONTSERRAT

juliusfergus@gmail.com

No.	Description	Date

SPCCU

OFFICE RENOVATION

ELECTRICAL PLAN		
Project number	0001	E-01
Date	16-01-2023	
Drawn by	Author	Scale As indicated
Designed by	Checker	